


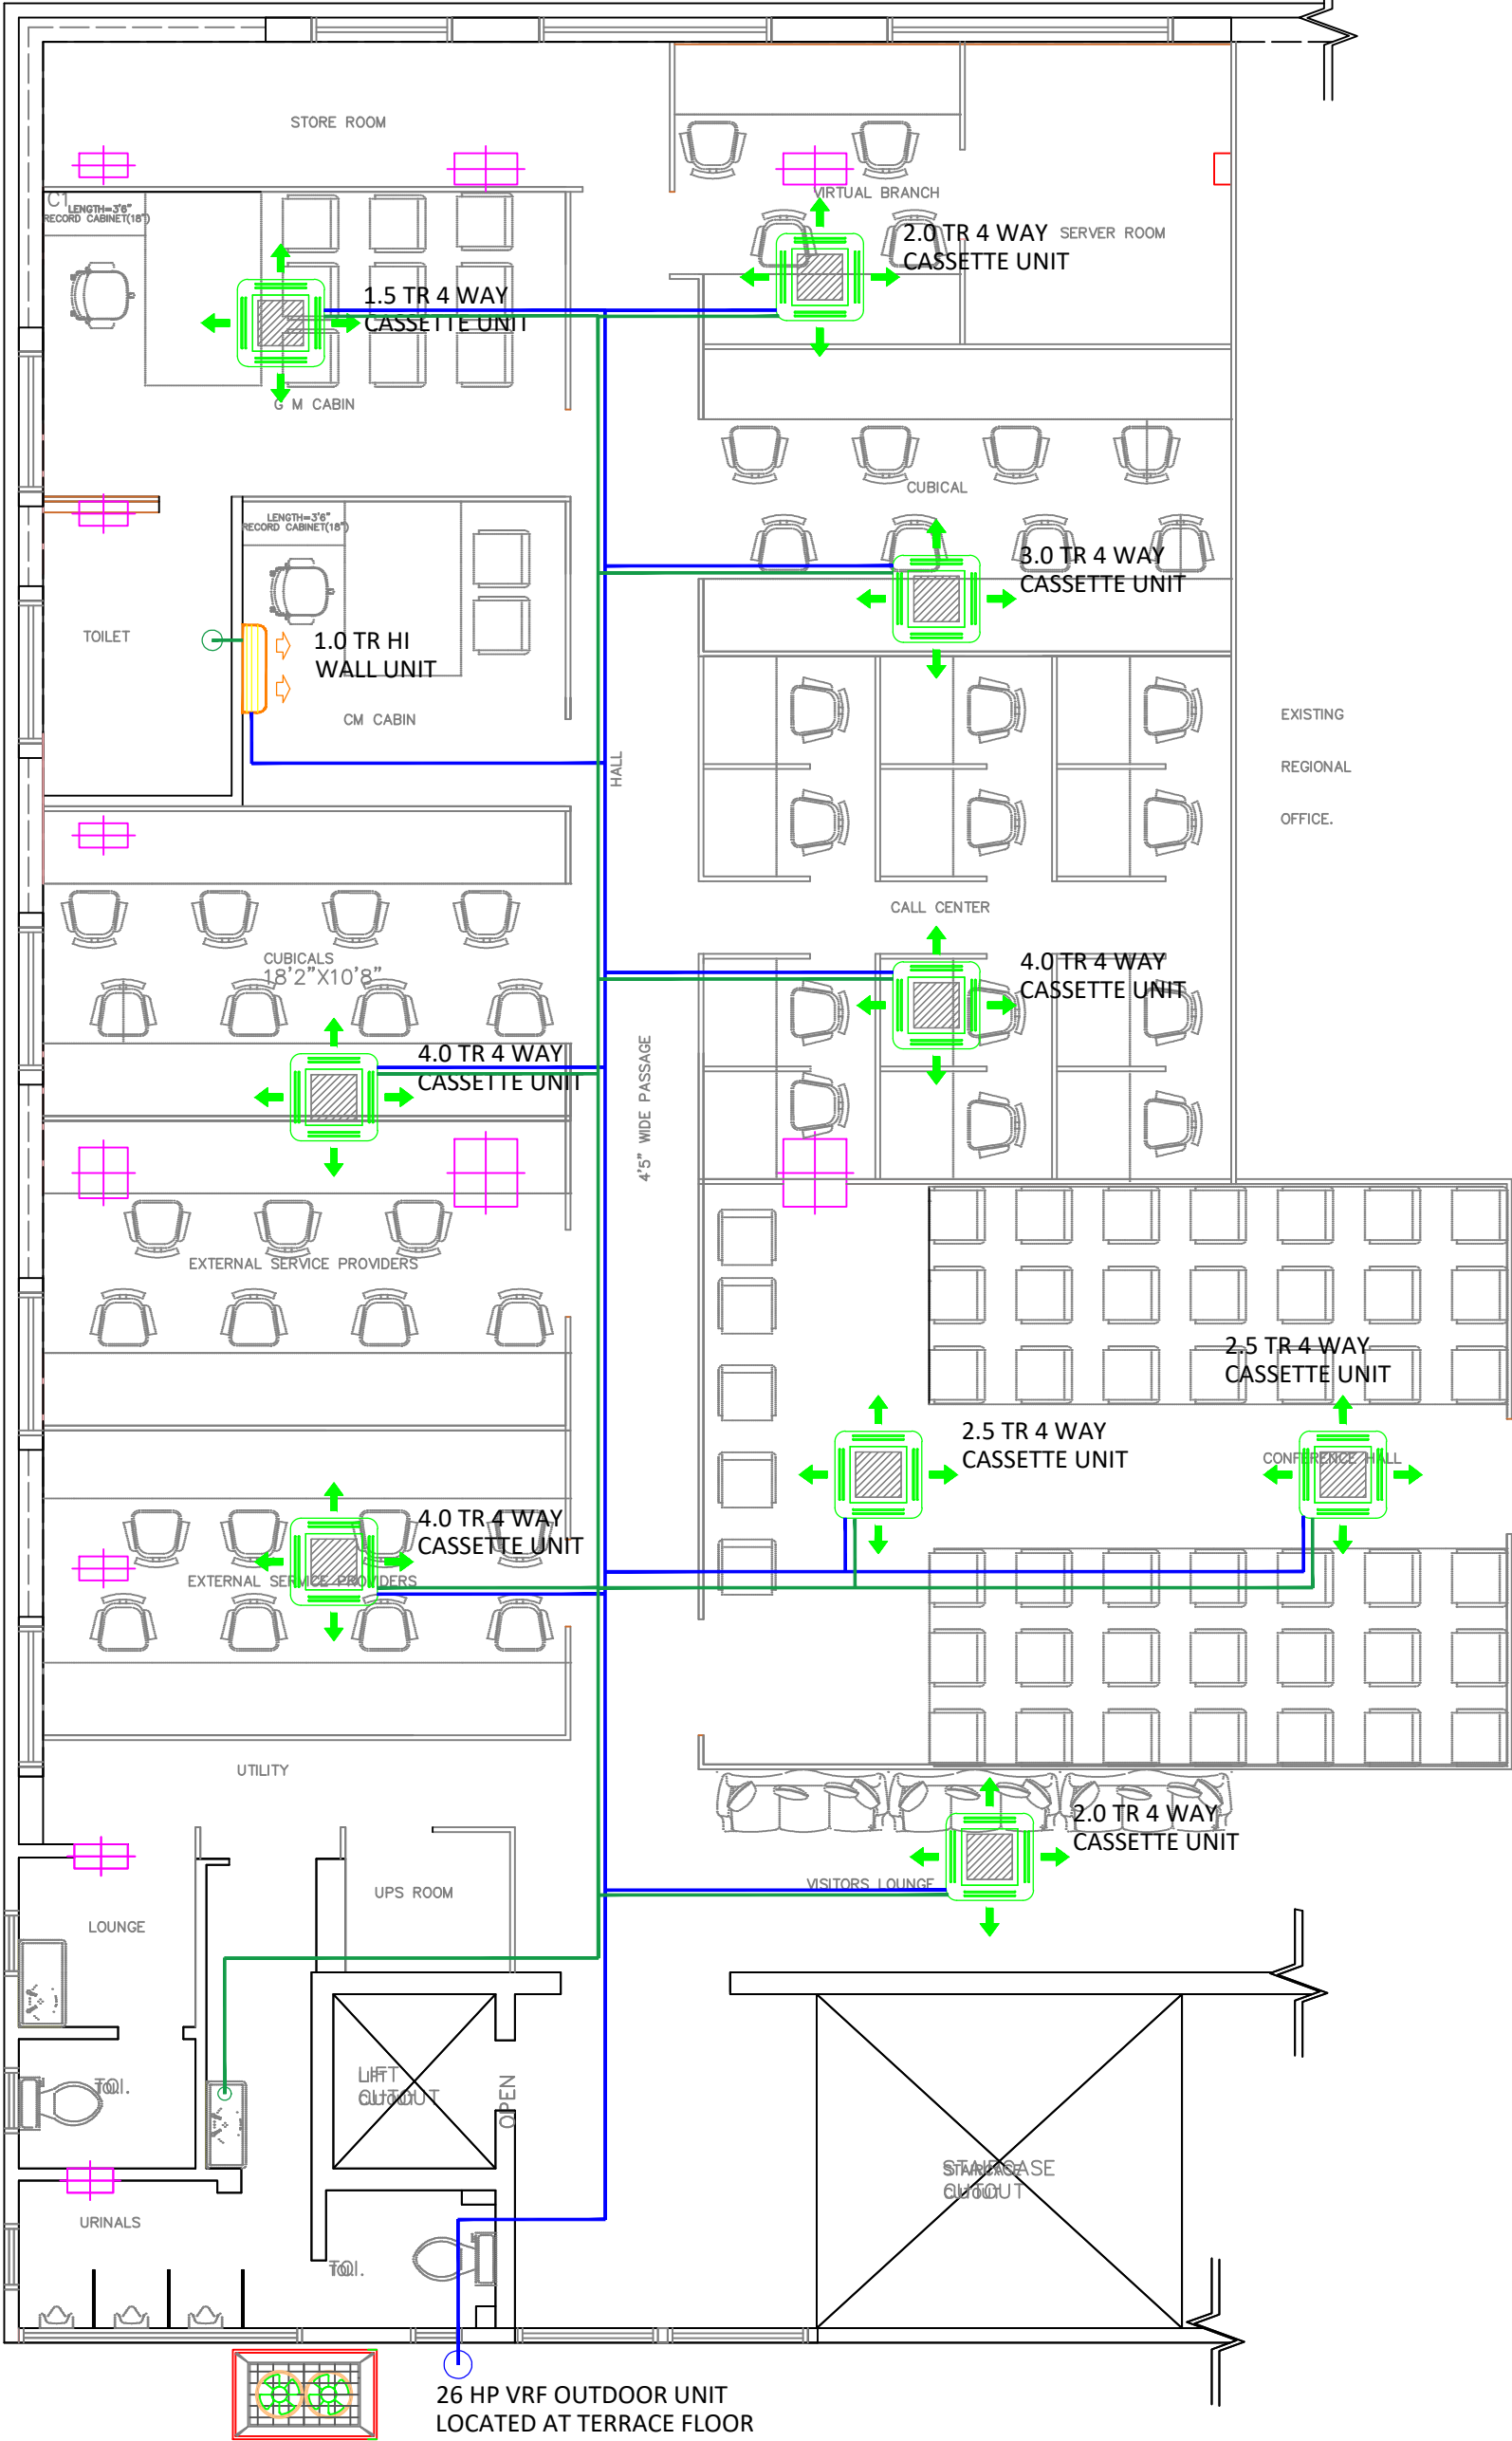

LEGEND	
MARK	DESCRIPTION
	Supply air duct
	Acoustic interal insulation
	Thermal insulation
	Linear supply/return air grill
	Y Branch (Refnet)
	Refrigerant Pipe
	25/40mm dia Drain pipe
	4 Way Cassette 600x600mm
	VRF Outdoor Unit
	FCU/Ductable unit
	Hi wall unit
	Trap door
	Cable Tray
	4" Sleeves
	Supply Air Diffuser - 600x600
	Return Air Diffuser - 600x600
	4 Way Cassette 900x900mm
	1 Way Cassette
	Ventilation Fan
	100/150mm Dia Disc Valve
	DX Outdoor Unit
	300x300 Supply Air Diffuser
	Volume Control Damper
	Flexible Duct
	100cfm Propeller Fan
	100cfm Cassette Type Exhaust Fan

REV	DATE	AMENDMENTS	DRAWN	APPD
ARCHITECT				
N.G.SHESHAGIRI RAO & ASSOCIATES				
ARCHITECTS, STRUCTURAL & CIVIL ENGINEERS				
NO 12, KRUMBIGAL ROAD,				
LALBAGH WEST GATE,MAVALLI,				
BANGALORE-560004				

MEP CONSULTANT	
#17 Annapurneshwari layout,	
Dasampura Nelamangala	
Bangalore - 562162	
Tel : +91 7019934428	
Web : www.skylineelectro.com	

PROJECT TITLE	
KARNATAKA GRAMEENA BANK,BANGALORE.	
DRAWING TITLE	
HVAC LAYOUT	
DRAWN	PR
DESIGNED	MAHENDRA
JOB No	SKY/2025/SE533
DRAWING No :	SE533-M-HVAC-01
REV	RO
*This document is a confidential property of the Skyline electro. We reserve all rights of this document & the information contained. Reproduction, use or disclosure of information in total or a part of it to the third party or to any unauthorized person is strictly forbidden & is liable for prosecution.- SKYLINE ELECTRO	

ISSUE PURPOSE
FOR TENDER